



2400 Reynolds Road
Suite 202
Winston-Salem, NC 27106
Phone 336 777 3657
Fax 336 777 3658
www.lambertal.com

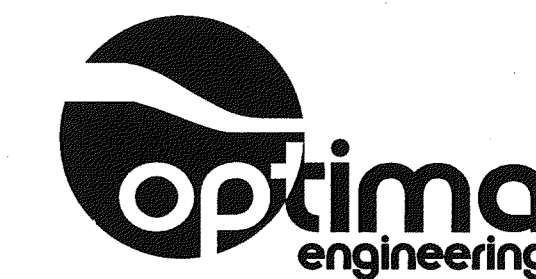


1927 South Tryon St., Suite 300, Charlotte NC 28203
Phone: 704-338-1292 • www.optima.com
North Carolina License Number: C-0914

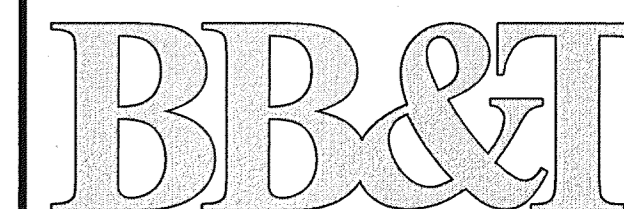

BRANCH BANK
701 VILLAGE WALK DRIVE
HOLLY SPRINGS, NC

BB&T PLANON # DEN-00000126

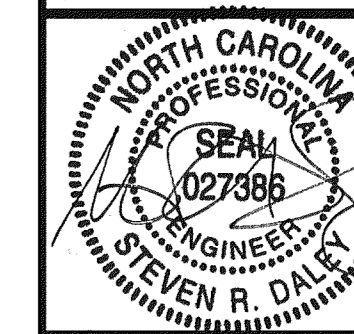


- 10-15-10
- OWNER REVIEW
 - PRELIMINARY DOCUMENTS
 - DESIGN DEVELOPMENT DOCUMENTS
 - PERMITTING DOCUMENTS
 - BID DOCUMENTS
 - CONSTRUCTION DOCUMENTS
 - RECORD DOCUMENTS

REVISIONS:

JOB NO: 10036
SHEET


M2.1 1 OF 3

DATE: 10/15/2010
DRAWN: CHD

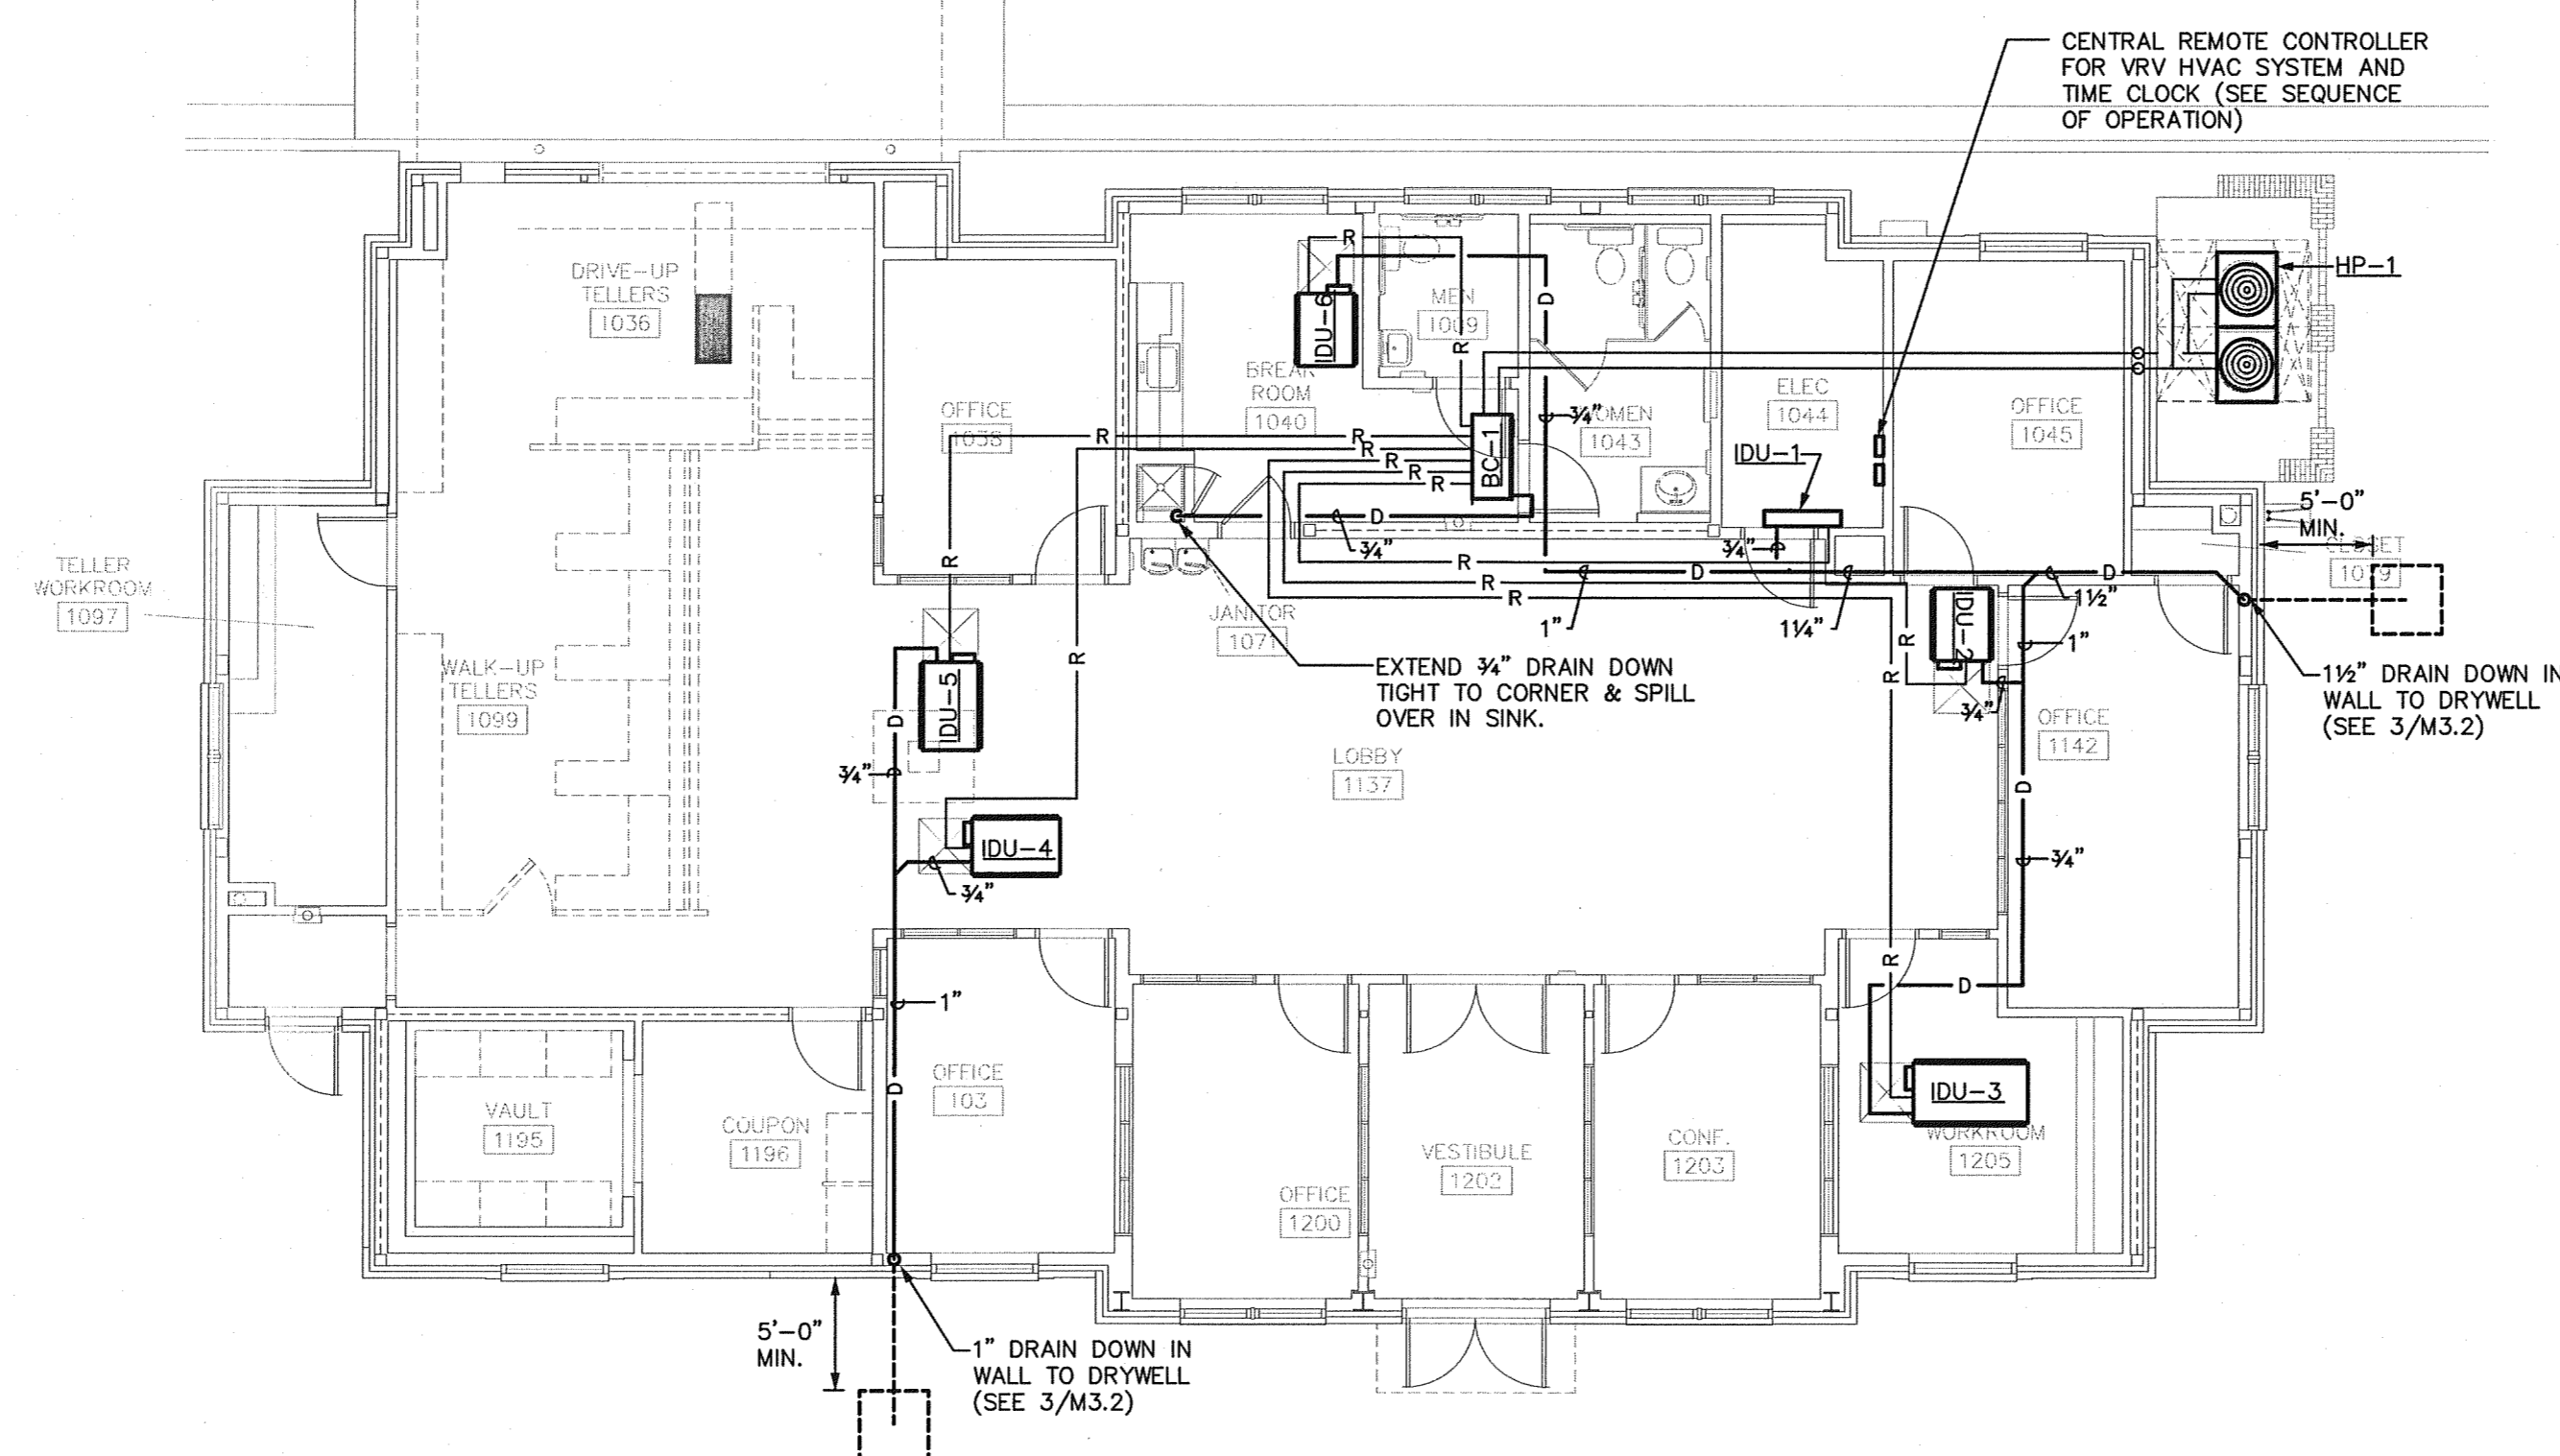

1 PIPING PLAN - MECHANICAL
1/8" = 1'-0"

- NOTES:
- MOUNT HEAT PUMP ON A 4" THICK CONCRETE PAD. EXTEND REFRIGERANT PIPING UP IN WALL AND ACROSS ABOVE CEILING TO BC CONTROLLER IN JAN CLOSET.
 - SEE ARCHITECTURAL PLANS FOR INFORMATION REGARDING LOCATIONS OF ROOF PENETRATIONS
 - DUCTWORK SHALL NOT BE LOCATED ABOVE ELECTRICAL PANELS. FIELD COORDINATE EXACT LOCATION OF DUCTWORK WITH ELECTRICAL CONTRACTOR.
 - MECHANICAL CONTRACTOR SHALL COORDINATE DUCTWORK AND UNIT LOCATIONS WITH ALL SOFFIT FRAMING AND CEILING HEIGHTS. SEE ARCHITECTURAL DRAWINGS FOR SOFFIT AND CEILING DETAILS.
 - GENERAL CONTRACTOR SHALL UNDERCUT THE FOLLOWING DOORS TO PROVIDE MAKE-UP FOR EXHAUST - TOILET ROOMS, BREAK ROOM, AND JANITOR'S CLOSET.
 - MOUNT INDOOR UNITS ON THE BOTTOM CHORDS OF THE TRUSSES. COORDINATE EXACT LOCATIONS TO MAINTAIN UNIT CLEARANCES AND FILTER ACCESS.
 - SEE ARCHITECTURAL FLOOR PLAN FOR EXACT LOCATION OF THERMOSTATS.

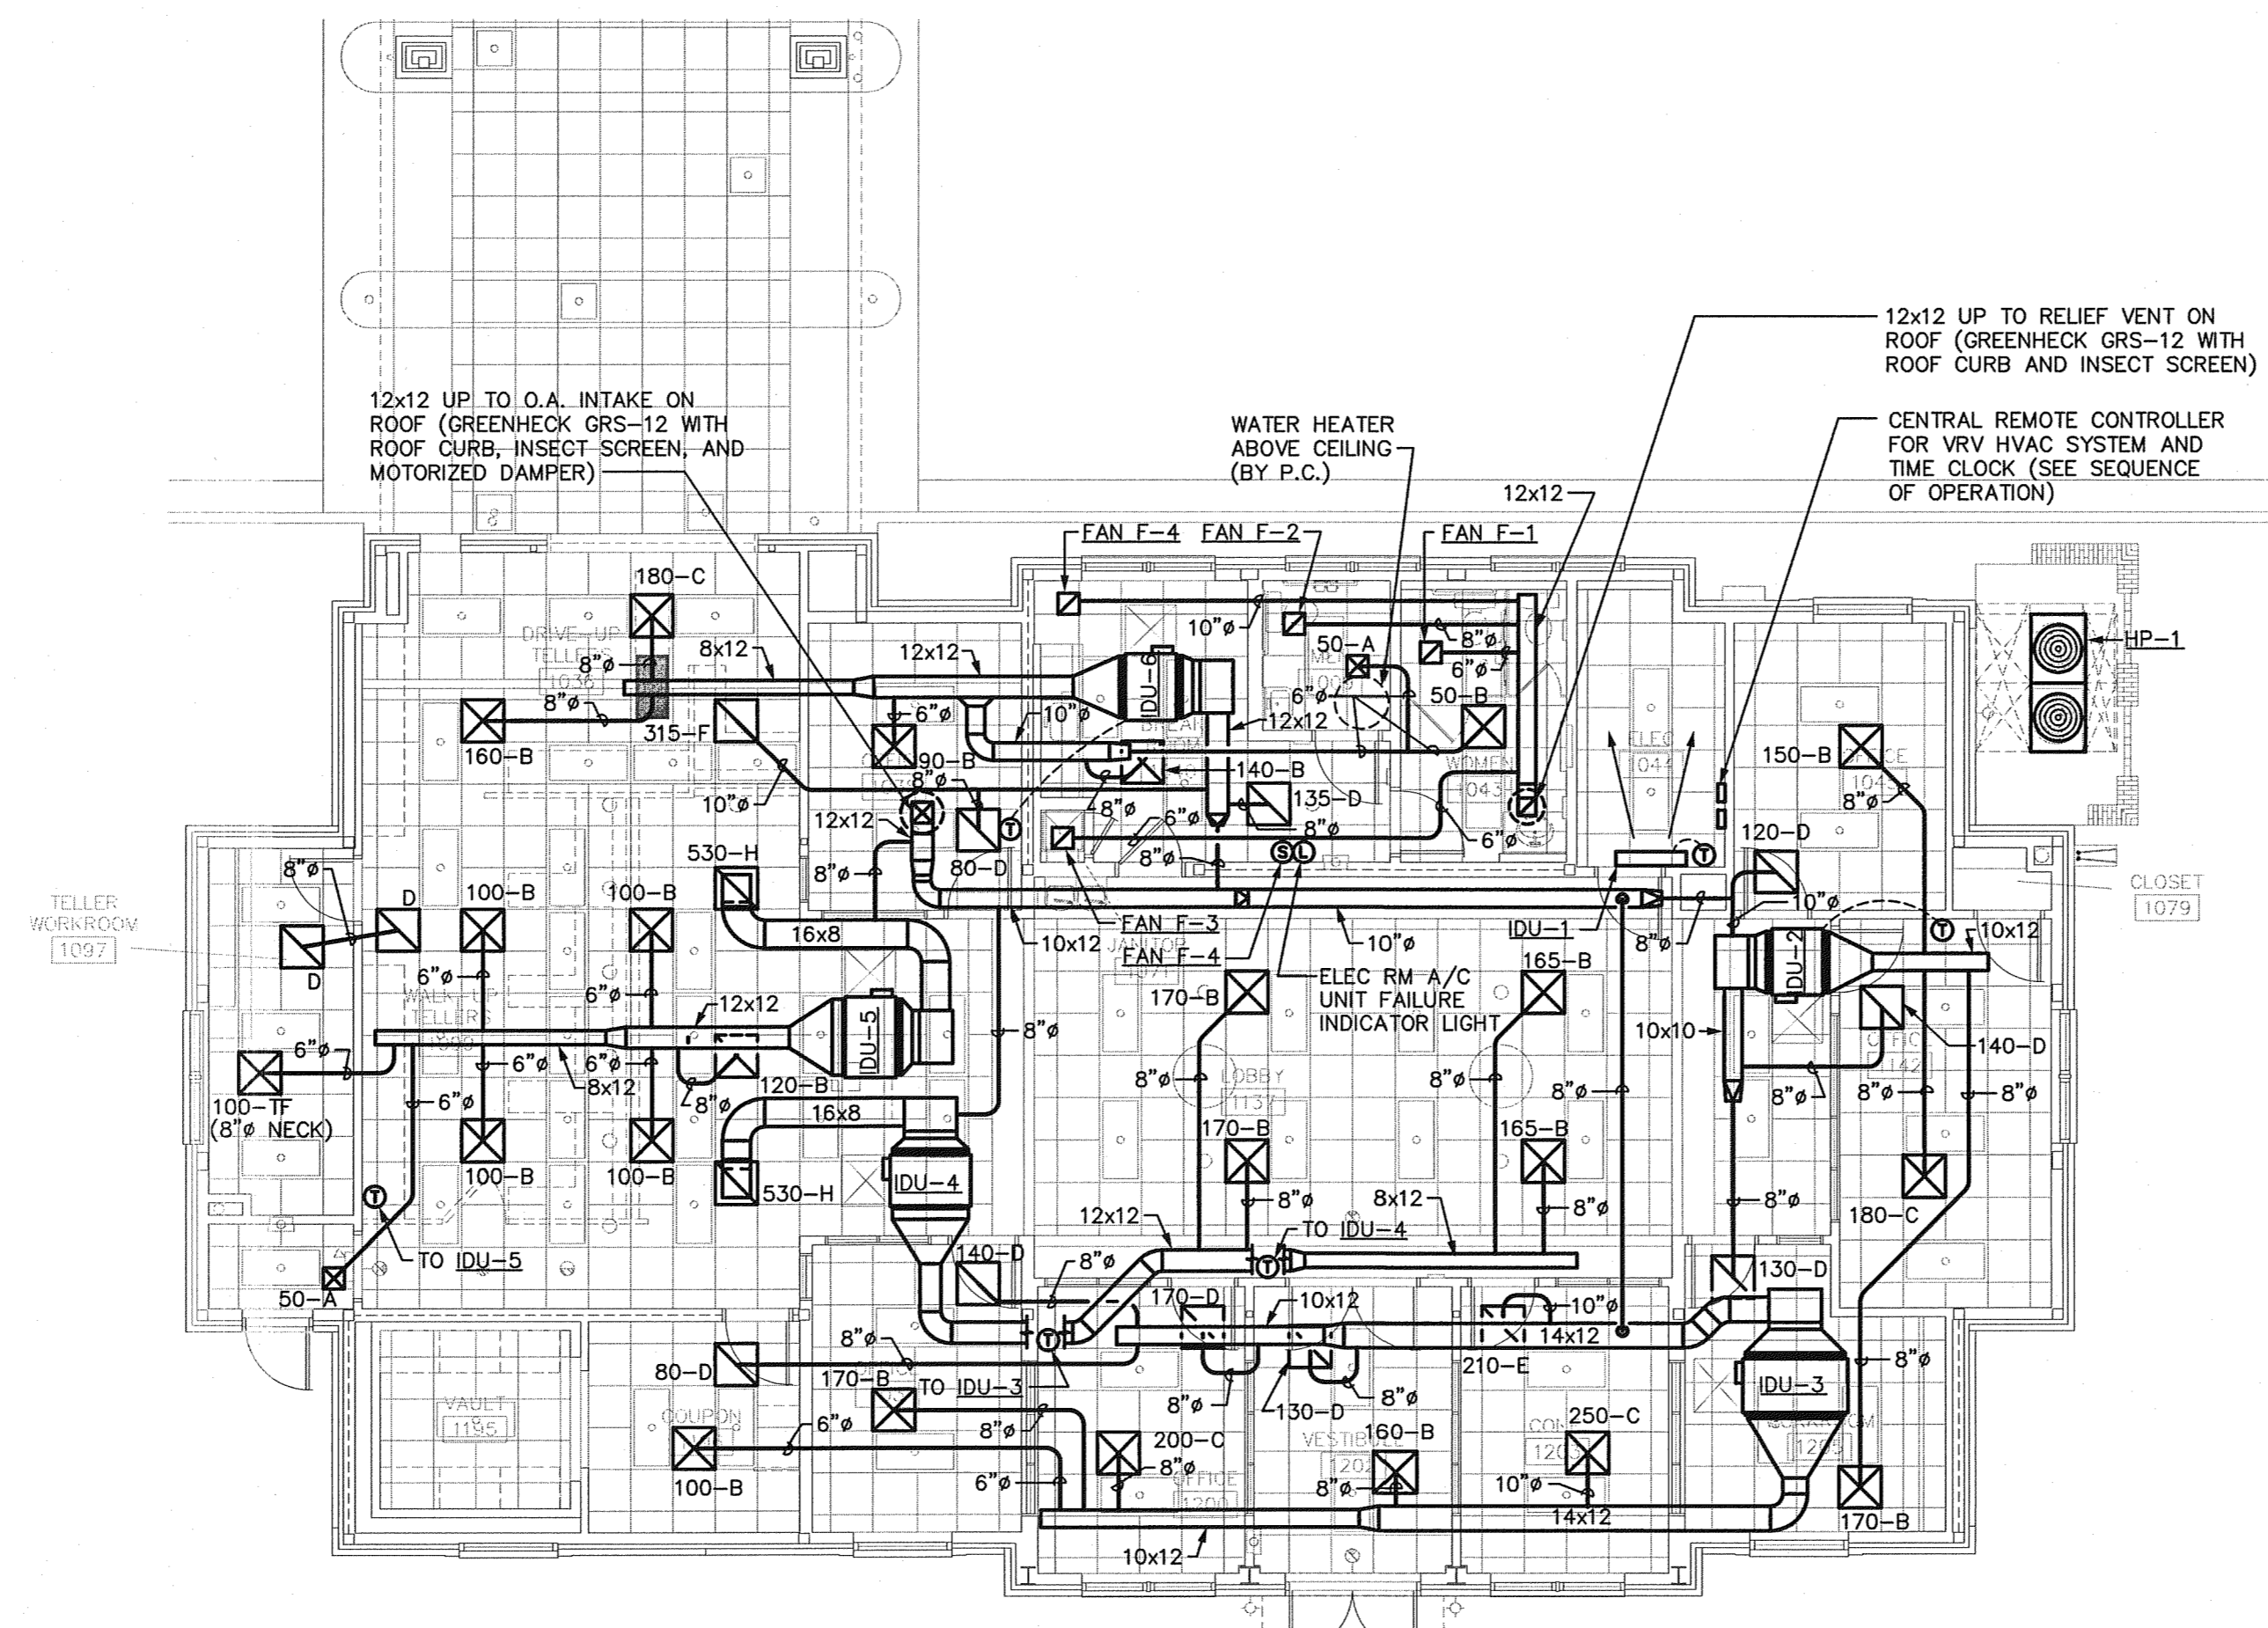

1 FLOOR PLAN - MECHANICAL
1/8" = 1'-0"